


REVISIONS				
REV	DATE	ECN NO.	DRAWN BY	DESCRIPTION
X1	6-11-18	N/A	RGB	RELEASE

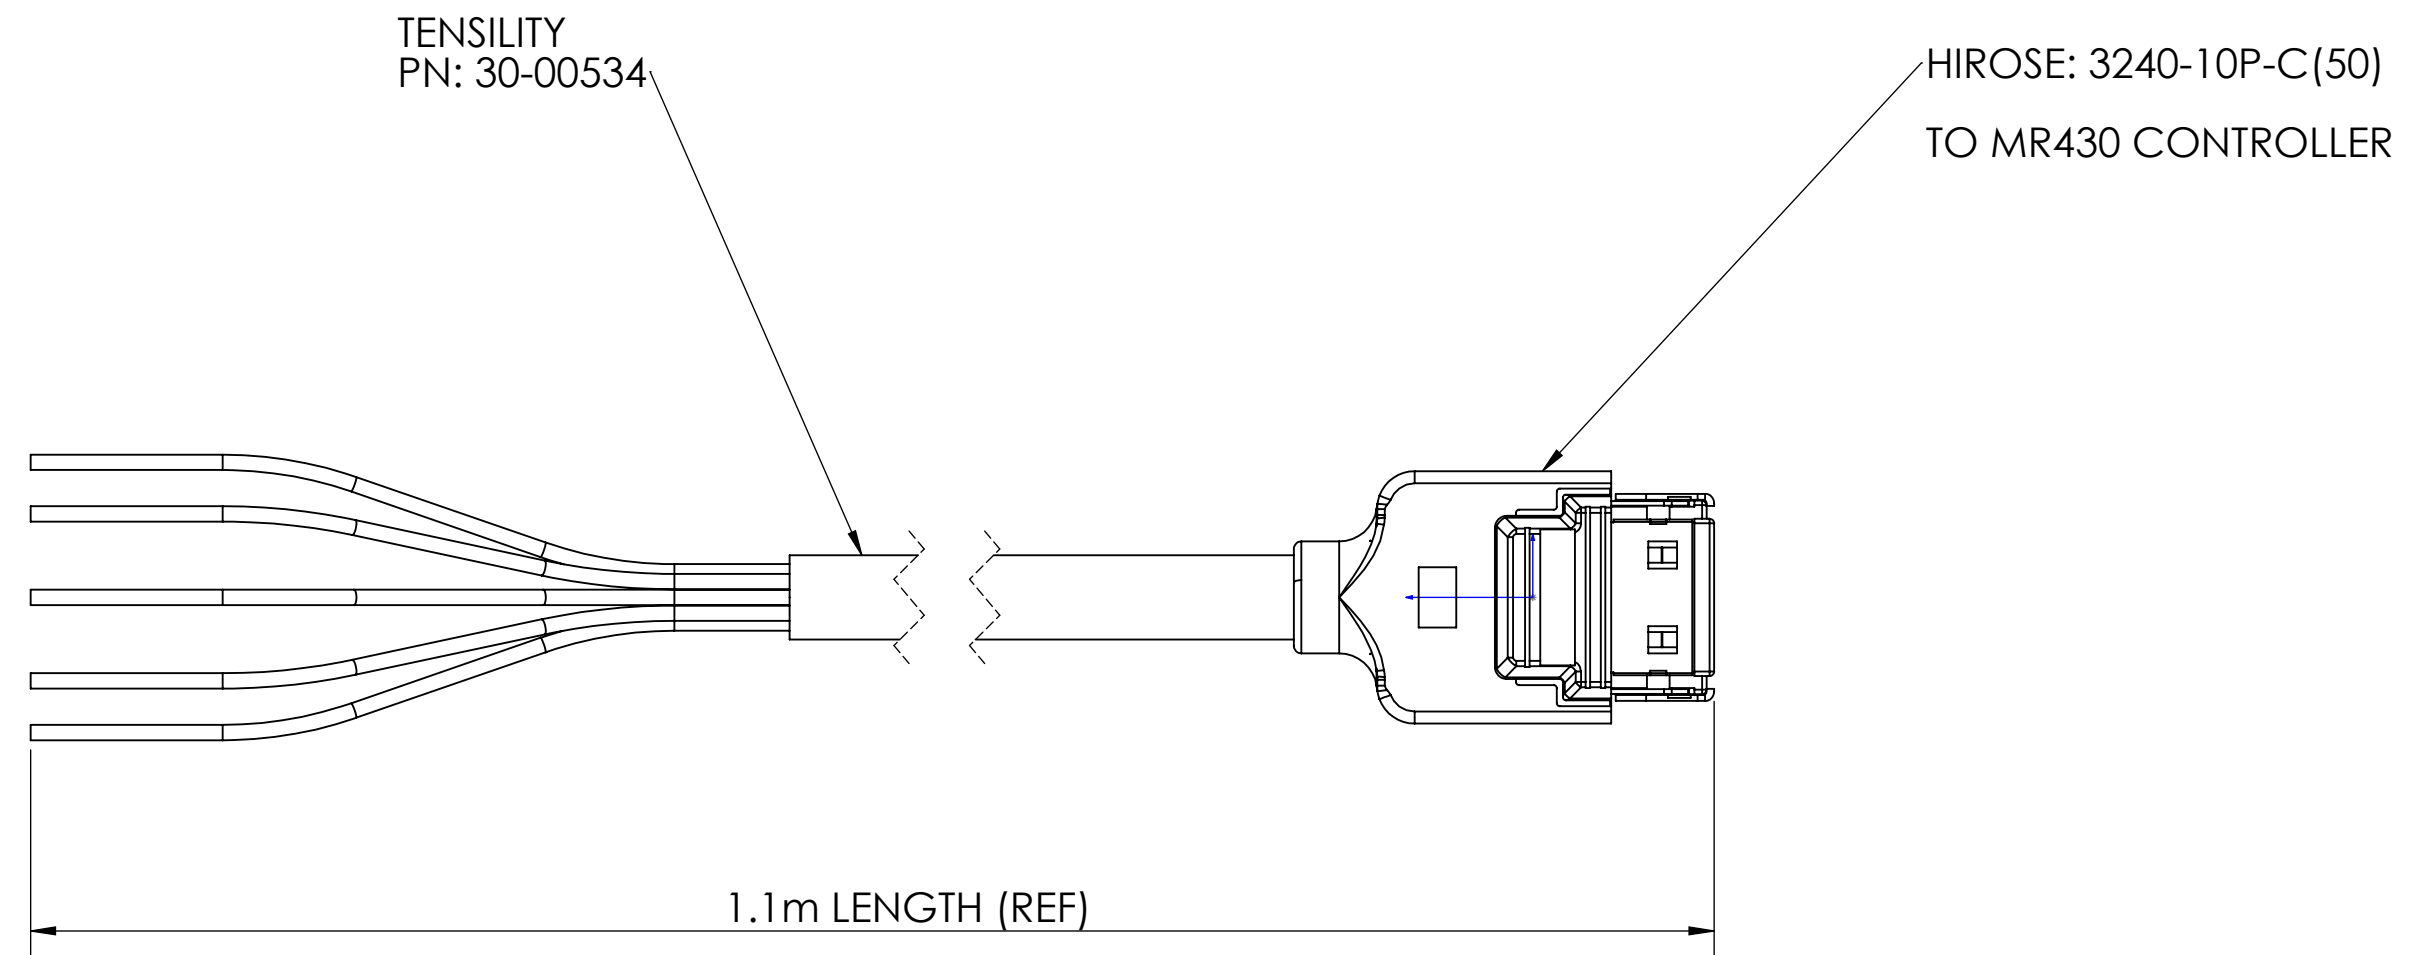


CONTROLLER CONNECTOR: Cable Plug: PN: 3240-10P-C(50)		
POSITION	FUNCTION	WIRE COLOR
1	+5V	BROWN
2	RS422 - RCV- (input)	RED
3	RS422 - RCV+ (input)	ORANGE
4	RS422 - TX- (output)	YELLOW
5	RS422 - TX+ (output)	GREEN
6	GND	BLUE
7	SSI-CLK-	PURPLE
8	SSI-CLK+	GREY
9	SSI-DAT-	WHITE
10	SSI-DAT+	BLACK

1 CABLES ARE MADE NOMINALLY 0.1m LONGER THAN SPECIFIED LENGTH.

NOTES: UNLESS OTHERWISE SPECIFIED

**PROPRIETARY AND CONFIDENTIAL**  
THE INFORMATION CONTAINED IN THIS DRAWING IS THE SOLE PROPERTY OF MICRONOR INC. ANY REPRODUCTION IN PART OR AS A WHOLE WITHOUT THE WRITTEN PERMISSION OF MICRONOR INC. IS PROHIBITED.

UNLESS OTHERWISE SPECIFIED: DIMENSIONS ARE IN INCHES		 <b>micronor</b> FIBER OPTIC KINETIC SENSORS WWW.MICRONOR.COM 805 389 6600	
<b>TOLERANCES:</b> TWO DECIMAL PLACE: ±.01 THREE DECIMAL PLACE: ±.004 FOUR DECIMAL PLACE: ±.0010 ANGULAR: ±.5°		TITLE:	
MATERIAL: SEE NOTES		<b>PIGTAIL ASSY, CONTROLLER CONNECTION</b>	
FINISH: SEE NOTES	DO NOT SCALE DRAWING	SIZE: <b>C</b> DWG. NO.: <b>MR430-99-01</b>	REV: <b>X1</b>
		SCALE: 2:1	SHEET: 1 OF 1